

Wanapitei Water Treatment Plant #4201

Rated Plant Capacity - 54,000 m³



LEGEND

Water Facilities

- Water Storage Tank
- Booster Station
- Well Pumphouse
- Water Distribution System

SUBDIVISION



Wastewater Facilities

- Wastewater Treatment Plant
- Sanitary Lagoon
- Lift Station
- Sanitary Collection System

Subdivision Activity Data

Designated Lands for development as per existing Official Plan.

Fire Flow < 75 L/s Available

Priority Land - (S) for Sewer (W) for Water
- Number of priority

NOTE: ALL FACILITY PLANS ARE APPROXIMATE AND FOR GRAPHIC ILLUSTRATION PURPOSES ONLY. PLEASE CONFIRM WITH THE CITY OF GREATER SUDBURY UTILITY PLANS FOR ACTUAL PLANT LOCATIONS.

WAHNAPITAE

Water Intake Pumphouse #4204

Robinson Booster Station #5302 (Decommissioned)

Wanapitei River
Receiving Stream for
Wahnapiatae Lagoon

WANAPITEI RIVER

Diverside

NOTE	REVISIONS		
	DATE	BY	DESCRIPTION
 DENNIS CONSULTANTS CIVIL ENGINEERS a division of R.V. Anderson Associates Limited	MAY 2005	S.N.S.	REVISED FINAL REPORT
 	WAHNAPITAE FIRE FLOW CONSTRAINTS		
	DRAWN BY: G.V.	DATE: MARCH 2005	N.T.S.

FIGURE 3.3.4d

LEGEND

Water Facilities

- Water Storage Tank
- Booster Station
- Well Pumphouse
- Water Distribution System

SUBDIVISION



Wastewater Facilities


- Wastewater Treatment Plant
- Sanitary Lagoon
- Lift Station
- Sanitary Collection System

Subdivision Activity Data

Designated Lands for development as per existing Official Plan.


Fire Flow < 75 L/s Available

Priority Land - (S) for Sewer (W) for Water
 # - Number of priority

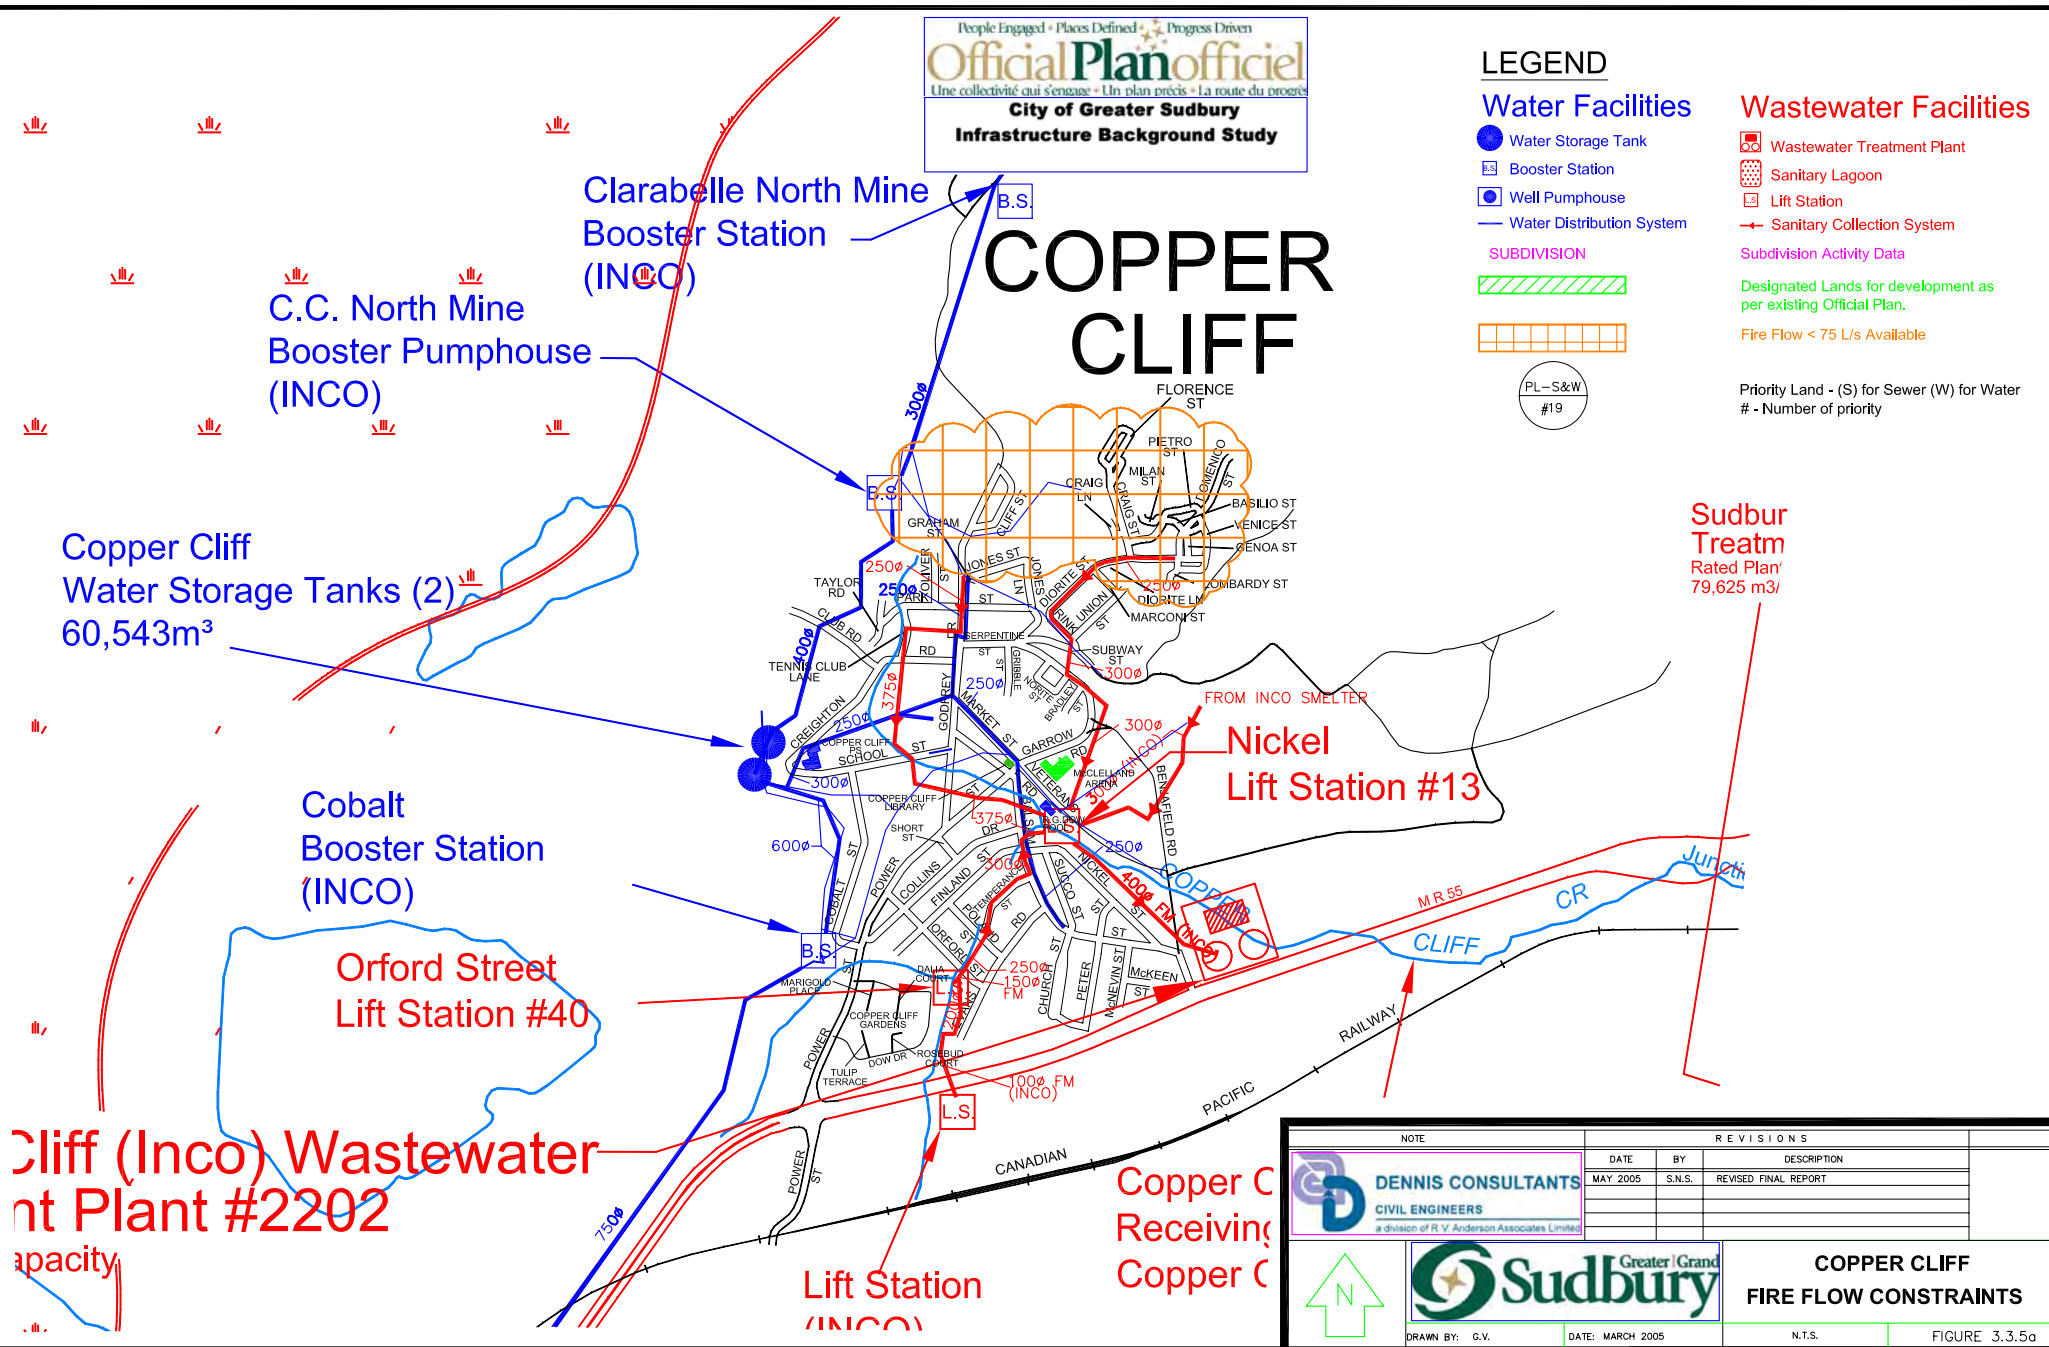

NOTE		R E V I S I O N S		
 DENNIS CONSULTANTS CIVIL ENGINEERS a division of R.V. Anderson Associates Limited	DATE	BY	DESCRIPTION	
	MAY 2005	S.N.S.	REVISED FINAL REPORT	

		COPPER CLIFF FIRE FLOW CONSTRAINTS	
		N.T.S.	FIGURE 3.3.5a
DRAWN BY: G.V.	DATE: MARCH 2005		

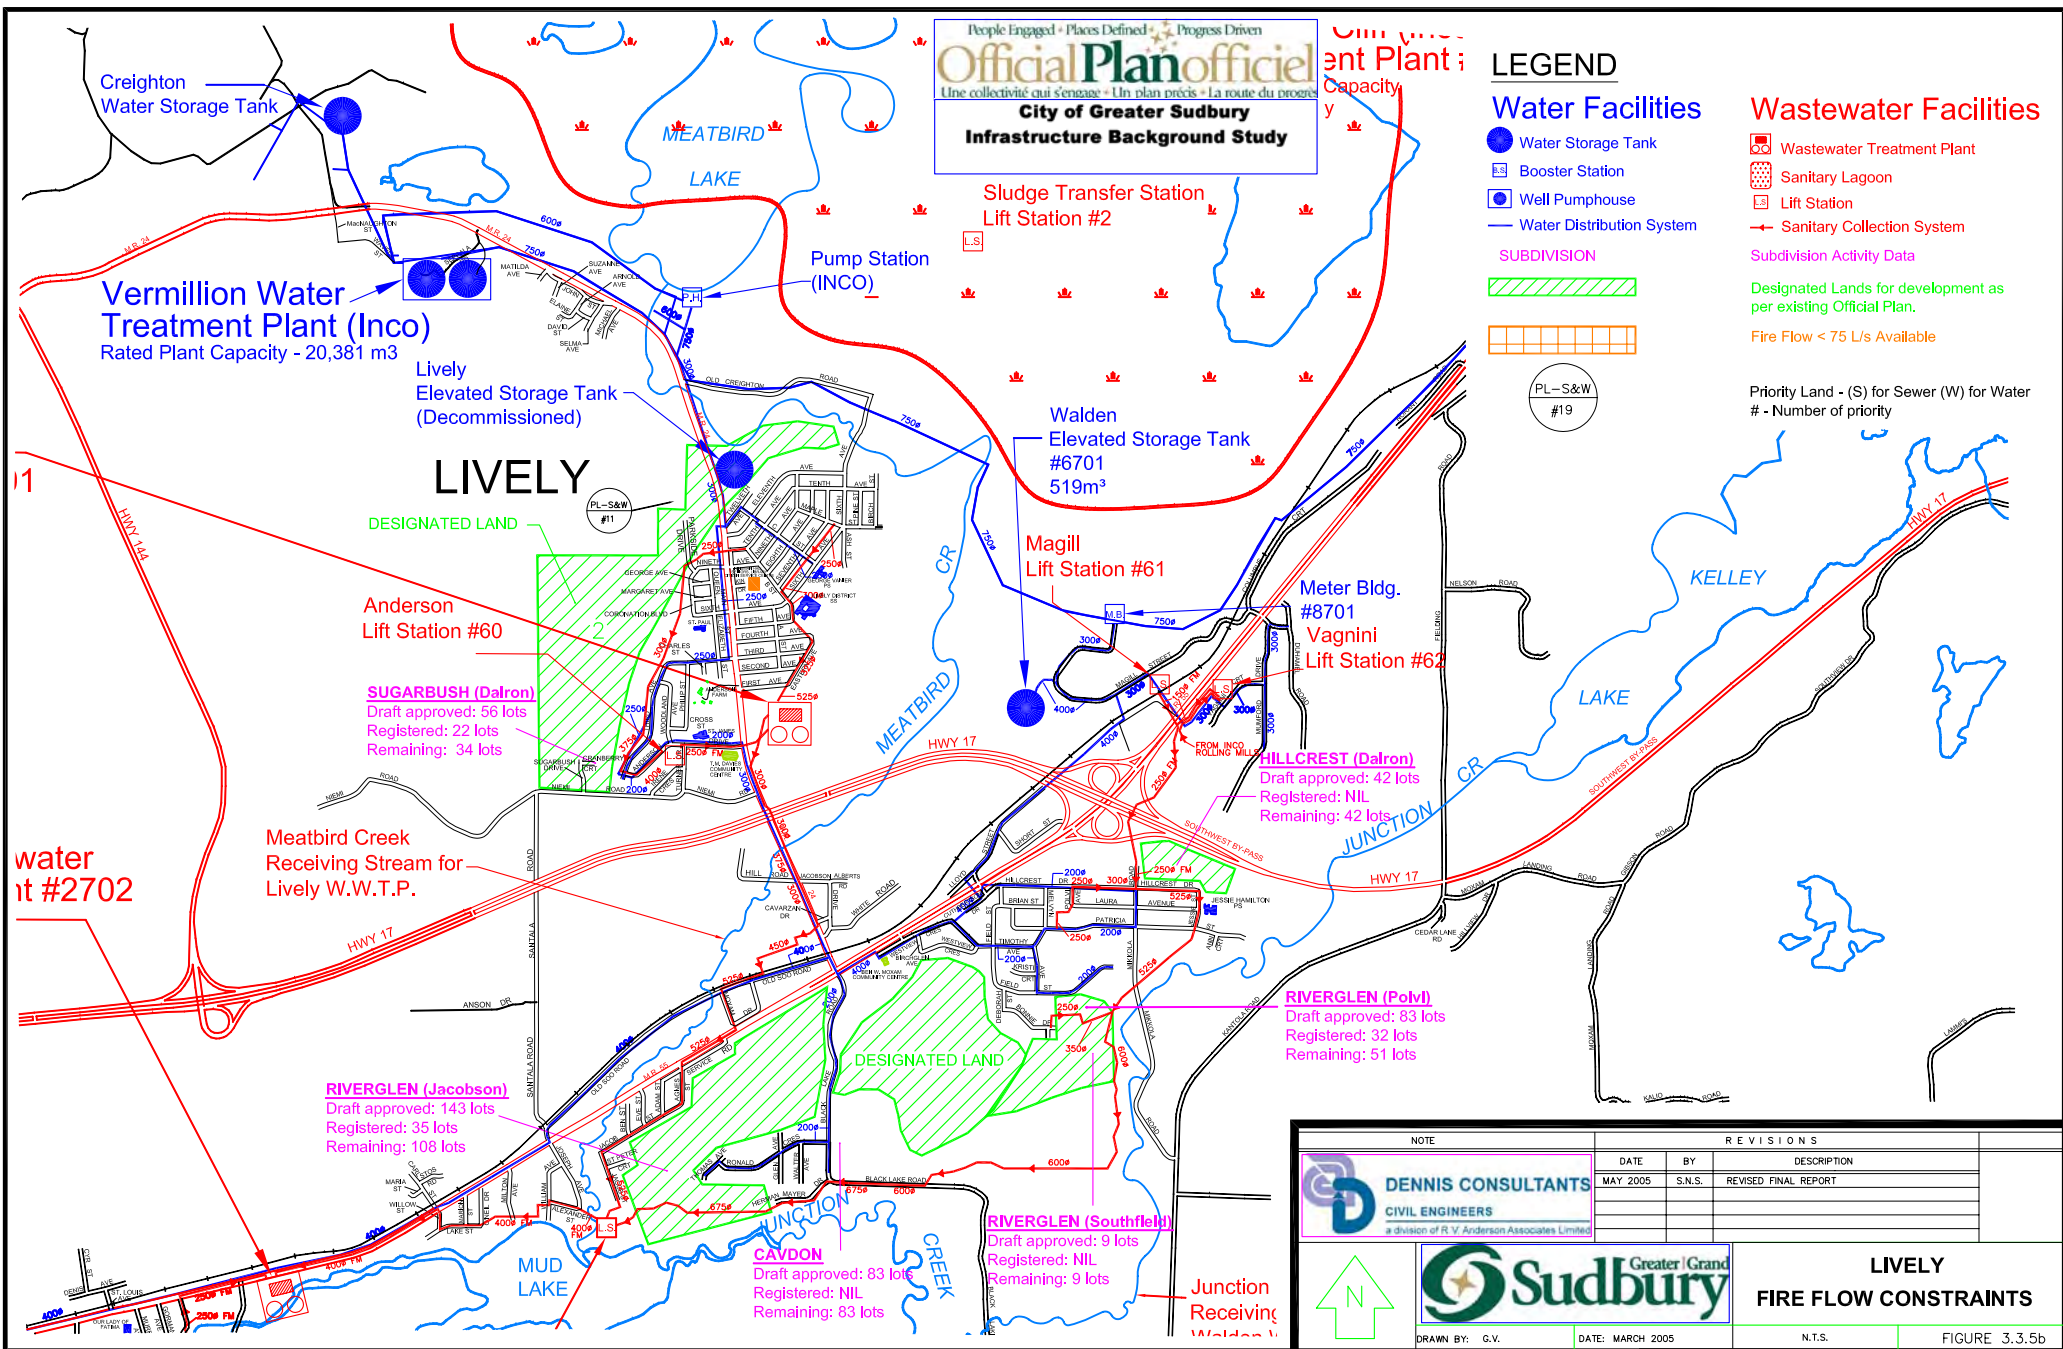

LEGEND

Water Facilities

- Water Storage Tank
- Booster Station
- Well Pumpouse
- Water Distribution System

SUBDIVISION



PL-S&W
#19

Wastewater Facilities

- Wastewater Treatment Plant
- Sanitary Lagoon
- Lift Station
- Sanitary Collection System

Subdivision Activity Data

Designated Lands for development as per existing Official Plan.

Fire Flow < 75 L/s Available

Priority Land - (S) for Sewer (W) for Water
- Number of priority

NAUGHTON

Walden Wastewater Treatment Plant #2702
 Rated Plant Capacity

Meatbird Creek
 Receiving Stream for
 Lively W.W.T.P.

RIVERGLEN (Jacobson)
 Draft approved: 143 lots
 Registered: 35 lots
 Remaining: 108 lots

CAVDON
 Draft approved: 83 lots
 Registered: NIL
 Remaining: 83 lots

Simon Lake West
 Lift Station #65

Simon Lake East
 Lift Station #64

Jacob
 Lift Station #63

Oja
 Lift Station #74

NOTE		REVISIONS	
 DENNIS CONSULTANTS CIVIL ENGINEERS a division of R.V. Anderson Associates Limited	DATE	BY	DESCRIPTION
	MAY 2005	S.N.S.	REVISED FINAL REPORT

		NAUGHTON FIRE FLOW CONSTRAINTS
	DRAWN BY: G.V.	

DATE: MARCH 2005	N.T.S.	FIGURE 3.3.5c
------------------	--------	---------------

People Engaged • Places Defined • Progress Driven

Official Plan officiel

Une collectivité qui s'engage • Un plan précis • La route du progrès

City of Greater Sudbury
Infrastructure Background Study

LEGEND

Water Facilities

- Water Storage Tank
- Booster Station
- Well Pumphouse
- Water Distribution System

SUBDIVISION



Wastewater Facilities

- Wastewater Treatment Plant
- Sanitary Lagoon
- Lift Station
- Sanitary Collection System


Subdivision Activity Data

Designated Lands for development as per existing Official Plan.

Fire Flow < 75 L/s Available

Priority Land - (S) for Sewer (W) for Water
- Number of priority

PL-S&W
#19

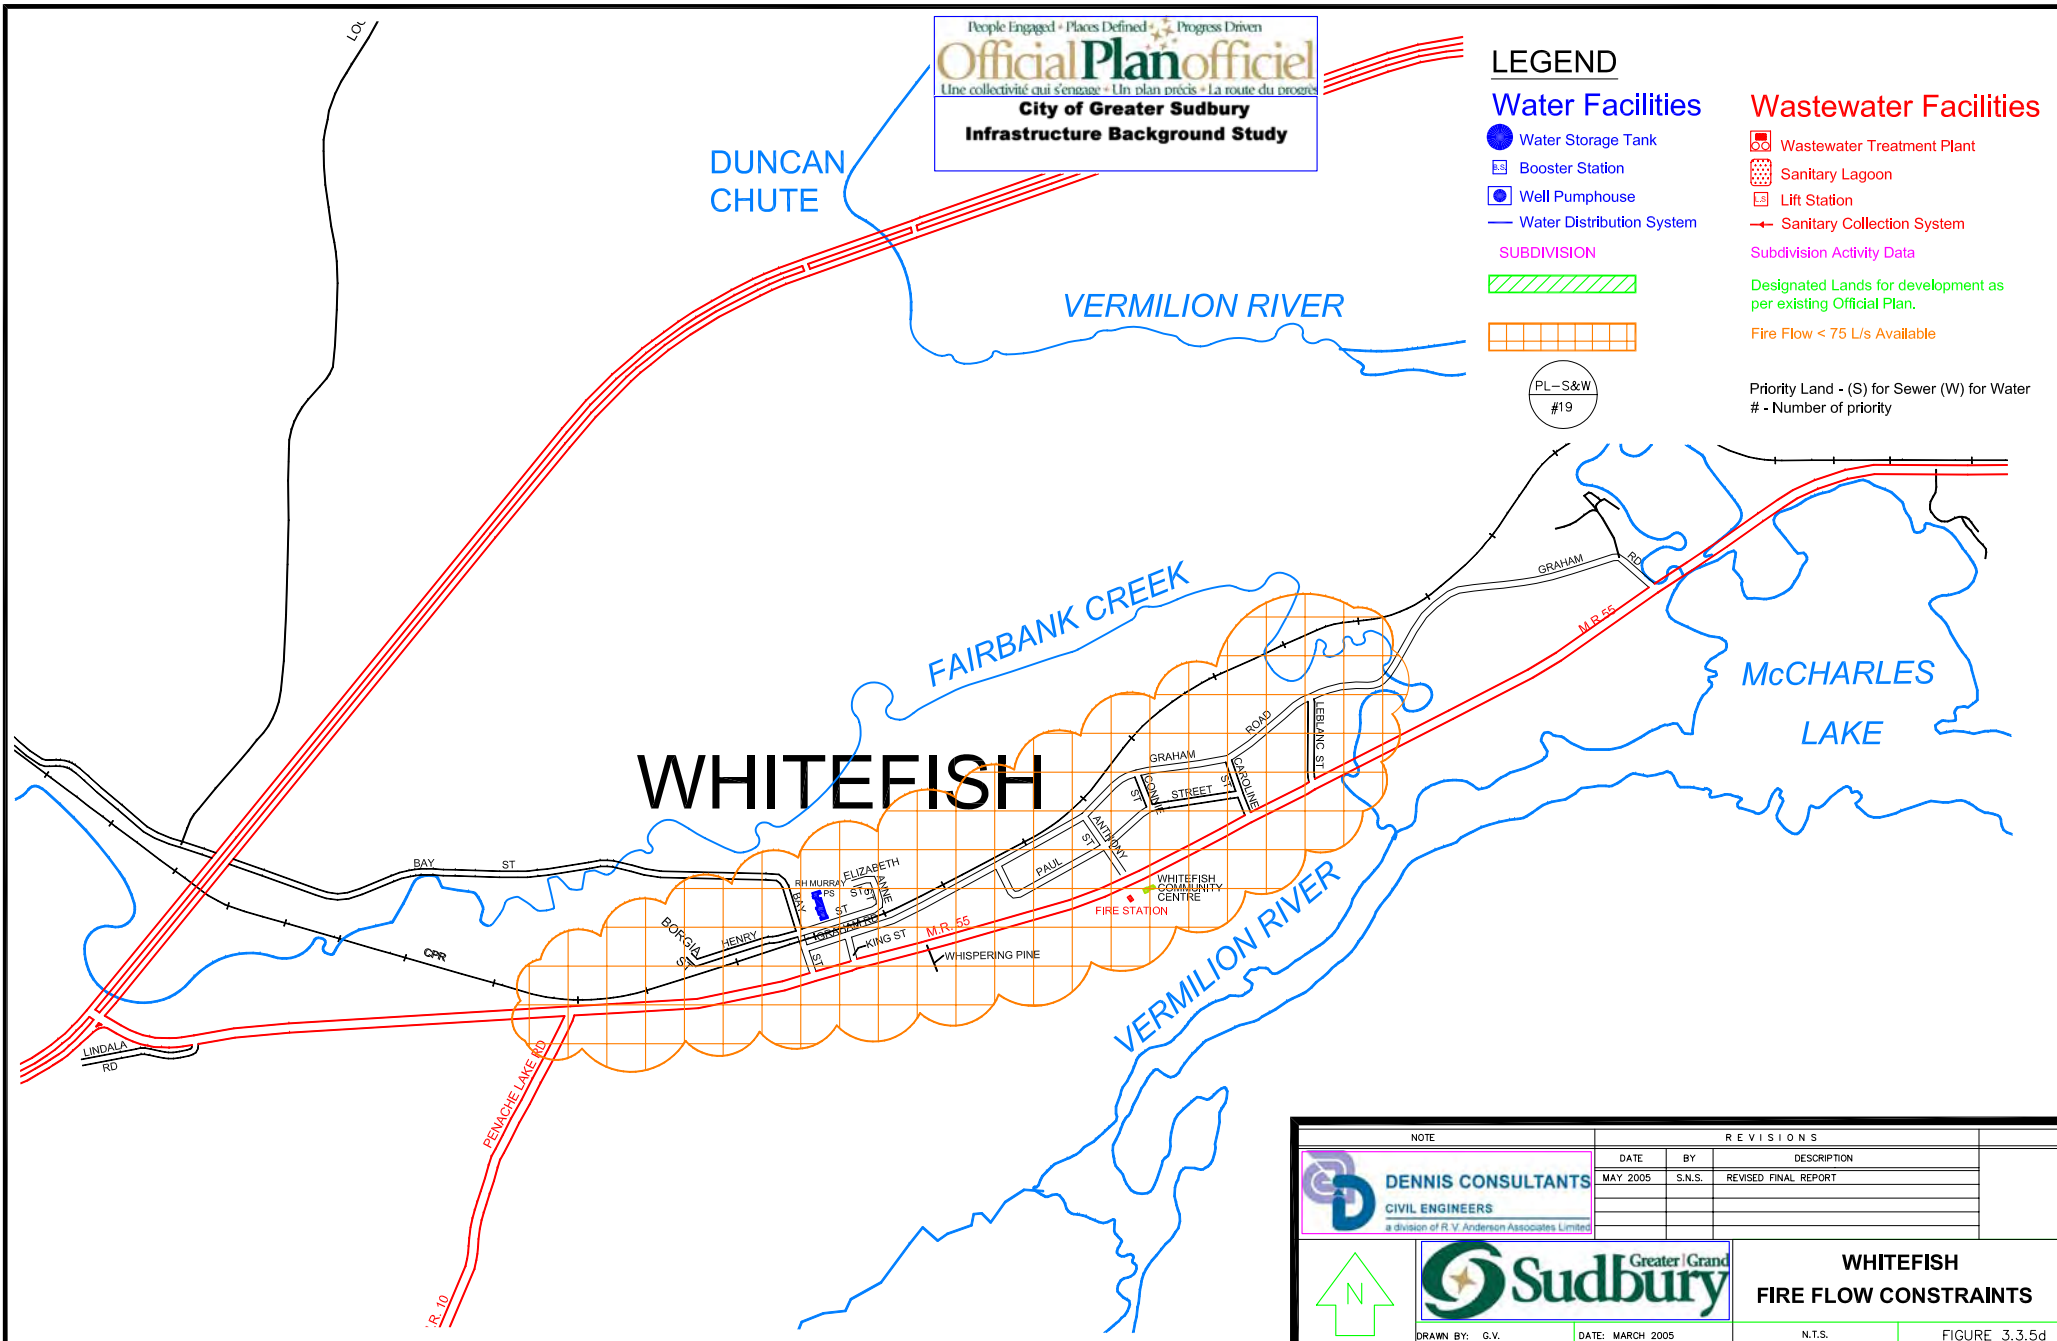

NOTE		R E V I S I O N S		
 DENNIS CONSULTANTS CIVIL ENGINEERS a division of R.V. Anderson Associates Limited	DATE	BY	DESCRIPTION	
	MAY 2005	S.N.S.	REVISED FINAL REPORT	
			WHITEFISH FIRE FLOW CONSTRAINTS	
	DRAWN BY: G.V.	DATE: MARCH 2005	N.T.S.	FIGURE 3.3.5d

People Engaged • Places Defined • Progress Driven

Official Plan officiel

Une collectivité qui s'engage • Un plan précis • La route du progrès

City of Greater Sudbury

Infrastructure Background Study

LEGEND

Water Facilities

- Water Storage Tank
- Booster Station
- Well Pumphouse
- Water Distribution System

SUBDIVISION



PL-S&W
#19

Wastewater Facilities


- Wastewater Treatment Plant
- Sanitary Lagoon
- Lift Station
- Sanitary Collection System

Subdivision Activity Data

Designated Lands for development as per existing Official Plan.

Fire Flow < 75 L/s Available

Priority Land - (S) for Sewer (W) for Water
- Number of priority

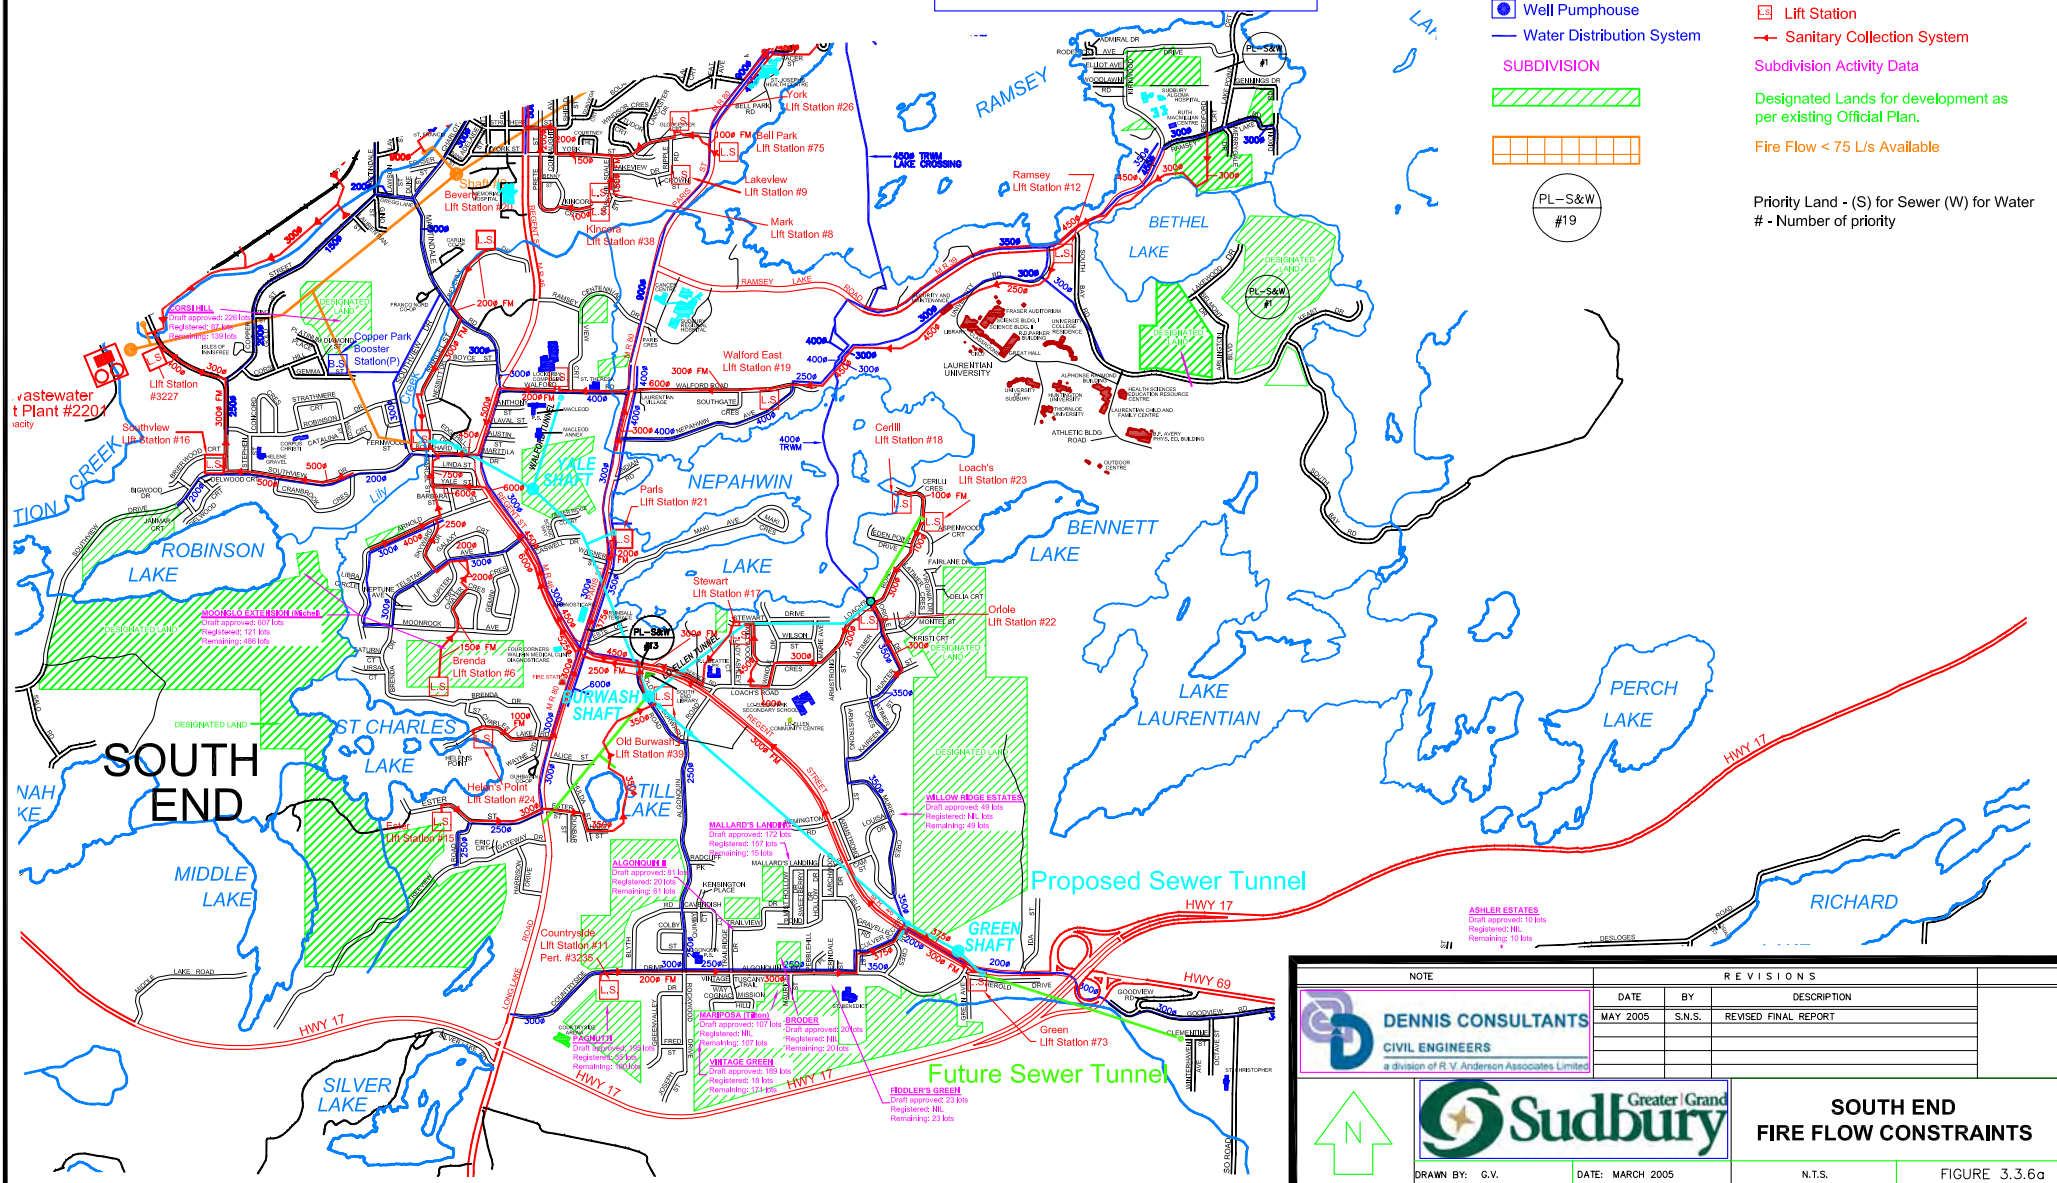

NOTE		REVISIONS		
 DENNIS CONSULTANTS CIVIL ENGINEERS a division of R. V. Anderson Associates Limited	DATE	BY	DESCRIPTION	
	MAY 2005	S.N.S.	REVISED FINAL REPORT	
			SOUTH END FIRE FLOW CONSTRAINTS	
	DRAWN BY: G.V.	DATE: MARCH 2005	N.T.S.	FIGURE 3.3.6a

People Engaged • Places Defined • Progress Driven

Official Plan officiel

Une collectivité qui s'engage • Un plan précis • La route du progrès

City of Greater Sudbury

Infrastructure Background Study

LEGEND

Water Facilities

- Water Storage Tank
- Booster Station
- Well Pump House
- Water Distribution System

SUBDIVISION



Wastewater Facilities


- Wastewater Treatment Plant
- Sanitary Lagoon
- Lift Station
- Sanitary Collection System

Subdivision Activity Data

Designated Lands for development as per existing Official Plan.


Fire Flow < 75 L/s Available

Priority Land - (S) for Sewer (W) for Water
- Number of priority

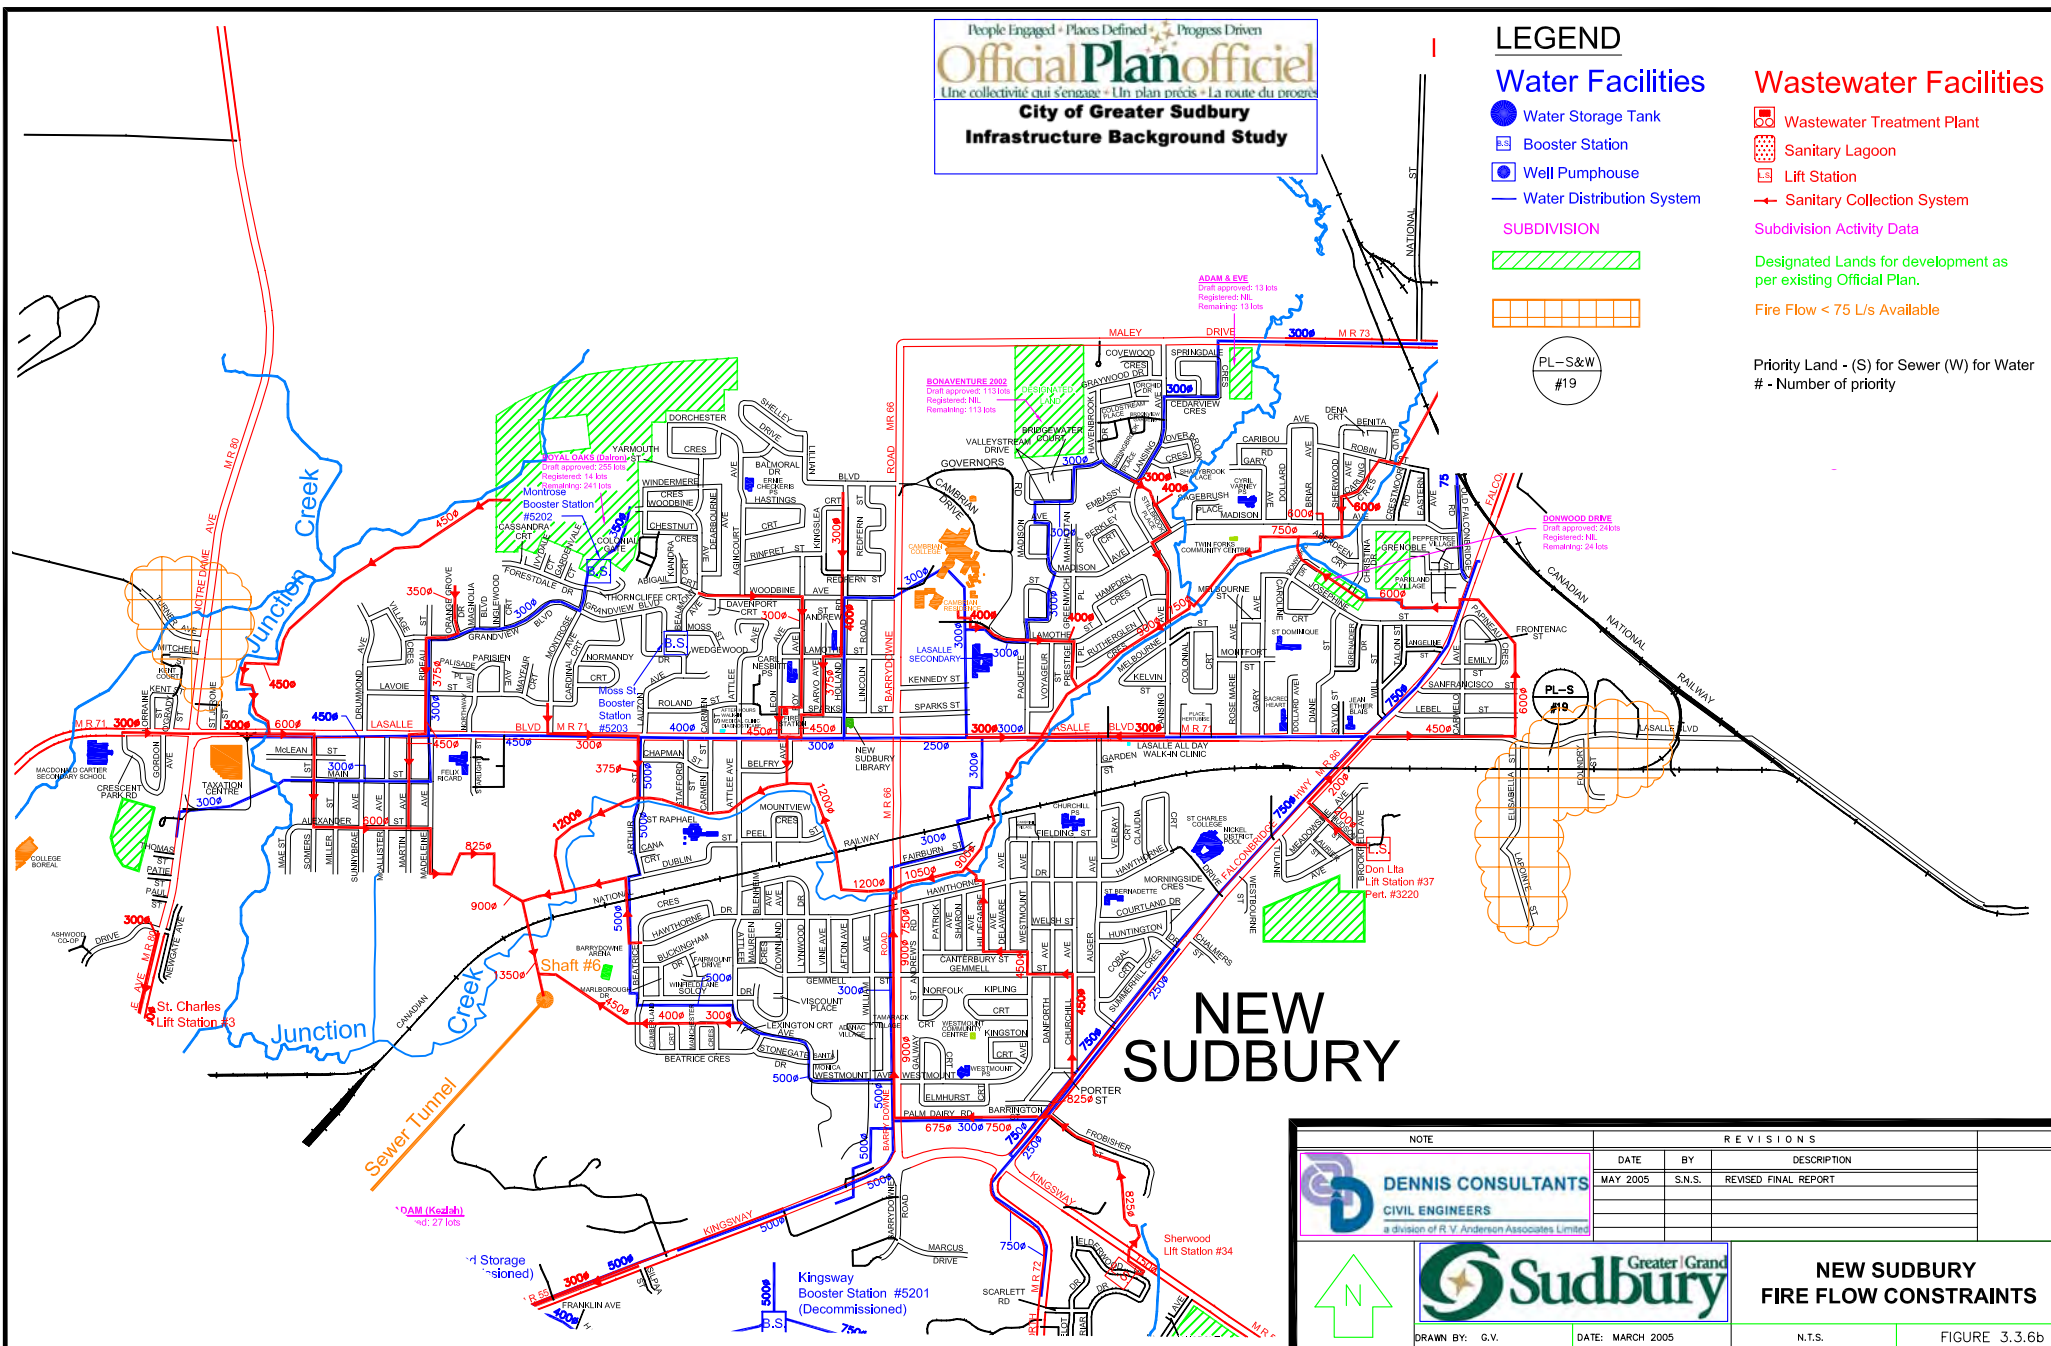

NOTE		REVISIONS		
DENNIS CONSULTANTS CIVIL ENGINEERS a division of R.V. Anderson Associates Limited		DATE	BY	DESCRIPTION
		MAY 2005	S.N.S.	REVISED FINAL REPORT
Greater Sudbury		NEW SUDBURY FIRE FLOW CONSTRAINTS		
		FIGURE 3.3.6b		

DRAWN BY: G.V. DATE: MARCH 2005 N.T.S.

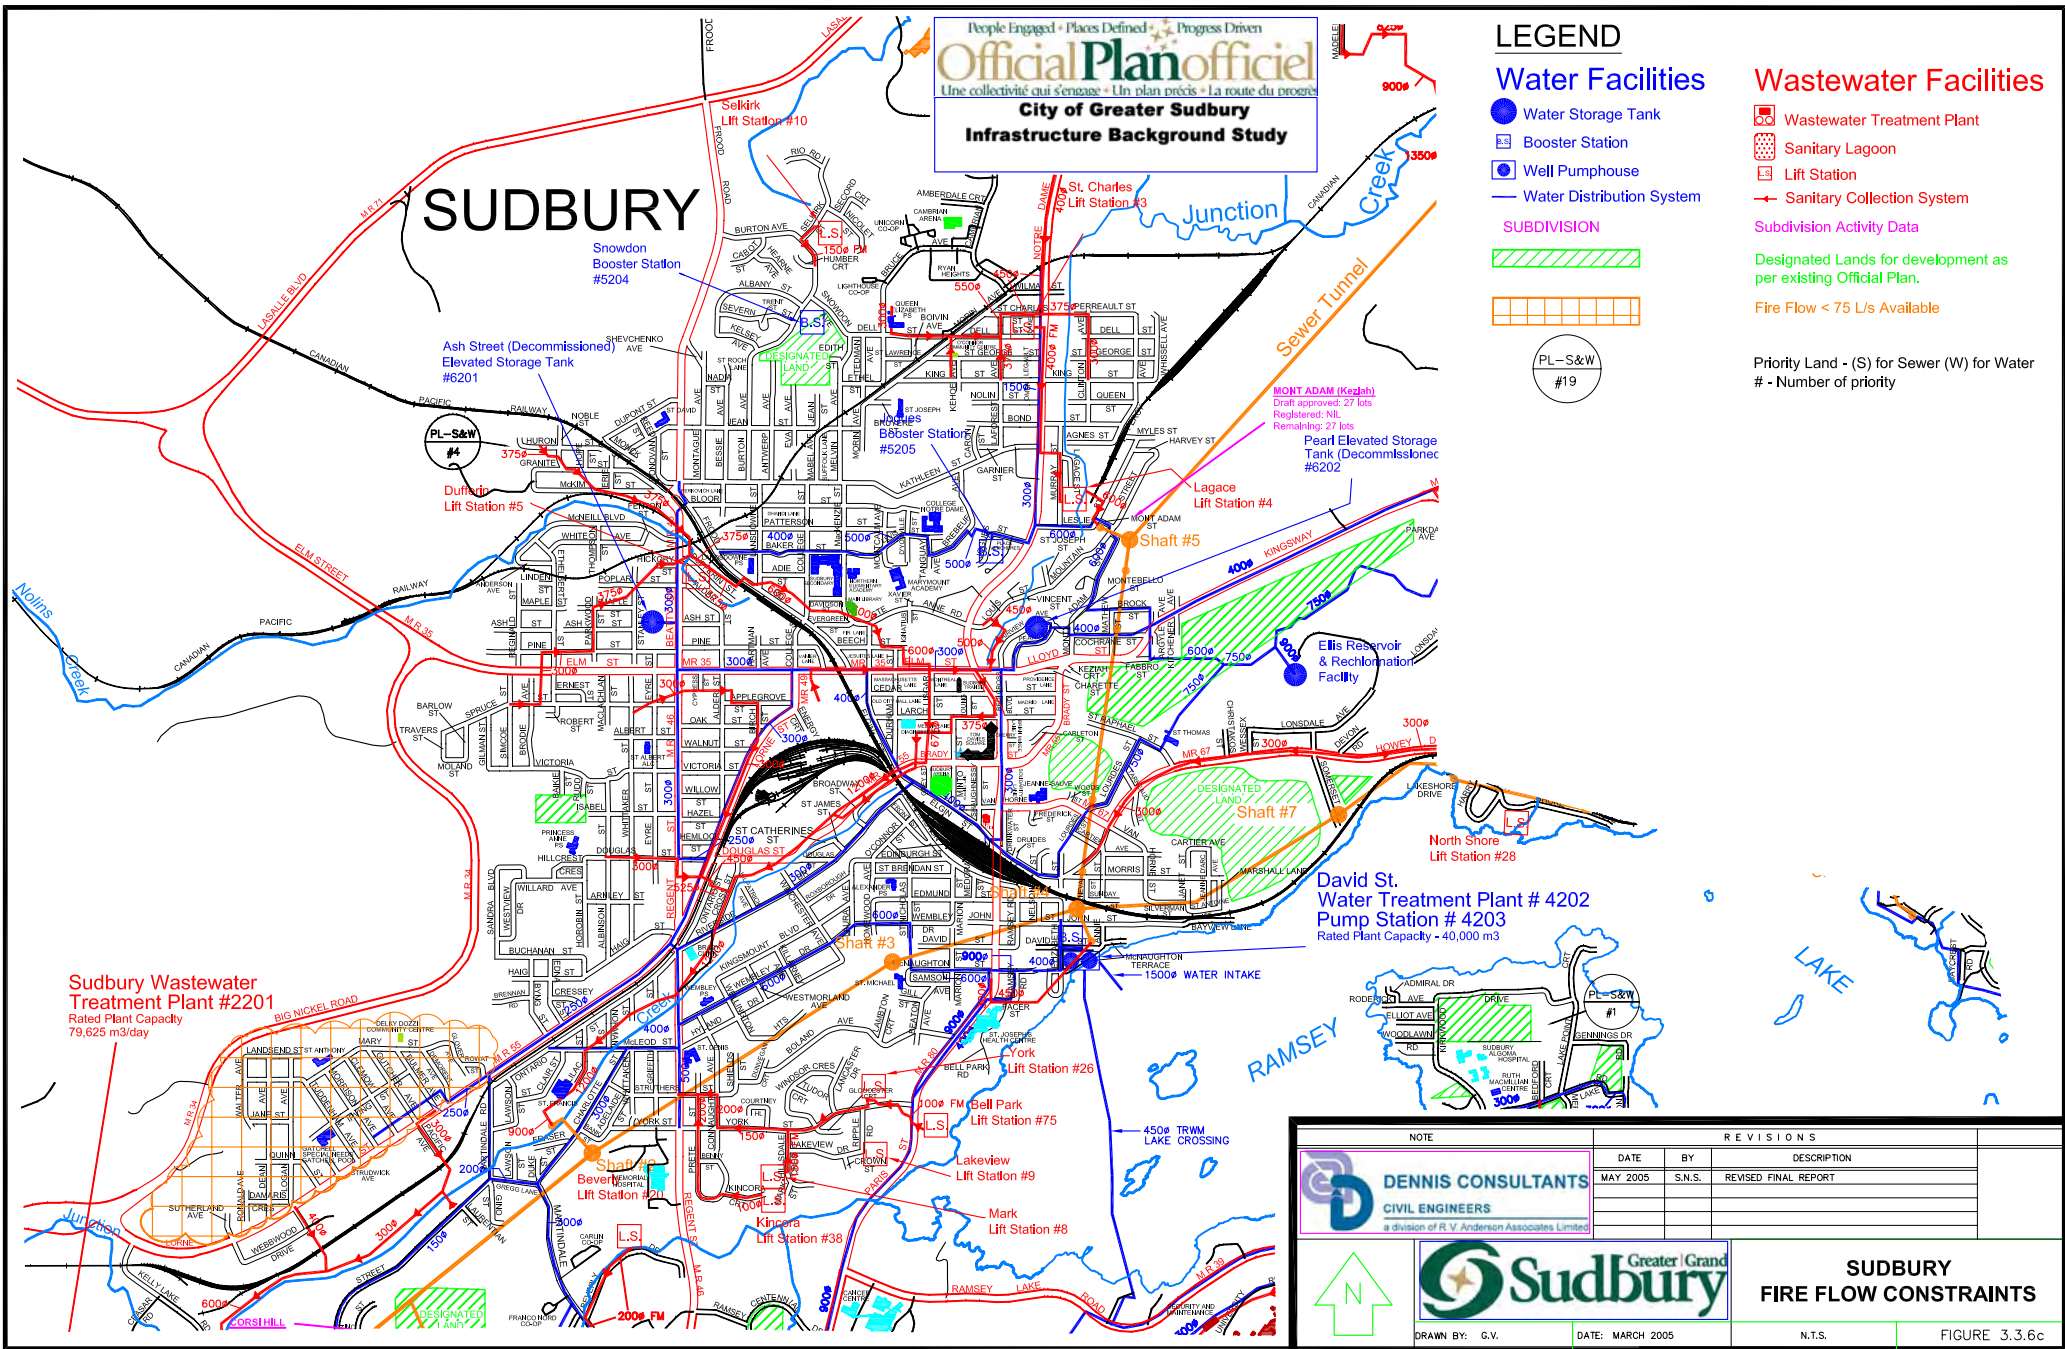

MINNOW LAKE

People Engaged • Places Defined • Progress Driven

Official Plan officiel

Une collectivité qui s'engage • Un plan précis • La route du progrès

City of Greater Sudbury

Infrastructure Background Study

LEGEND

Water Facilities

- Water Storage Tank
- Booster Station
- Well Pumpouse
- Water Distribution System

SUBDIVISION



Wastewater Facilities


- Wastewater Treatment Plant
- Sanitary Lagoon
- Lift Station
- Sanitary Collection System

Subdivision Activity Data

Designated Lands for development as per existing Official Plan.

Fire Flow < 75 L/s Available

Priority Land - (S) for Sewer (W) for Water
- Number of priority

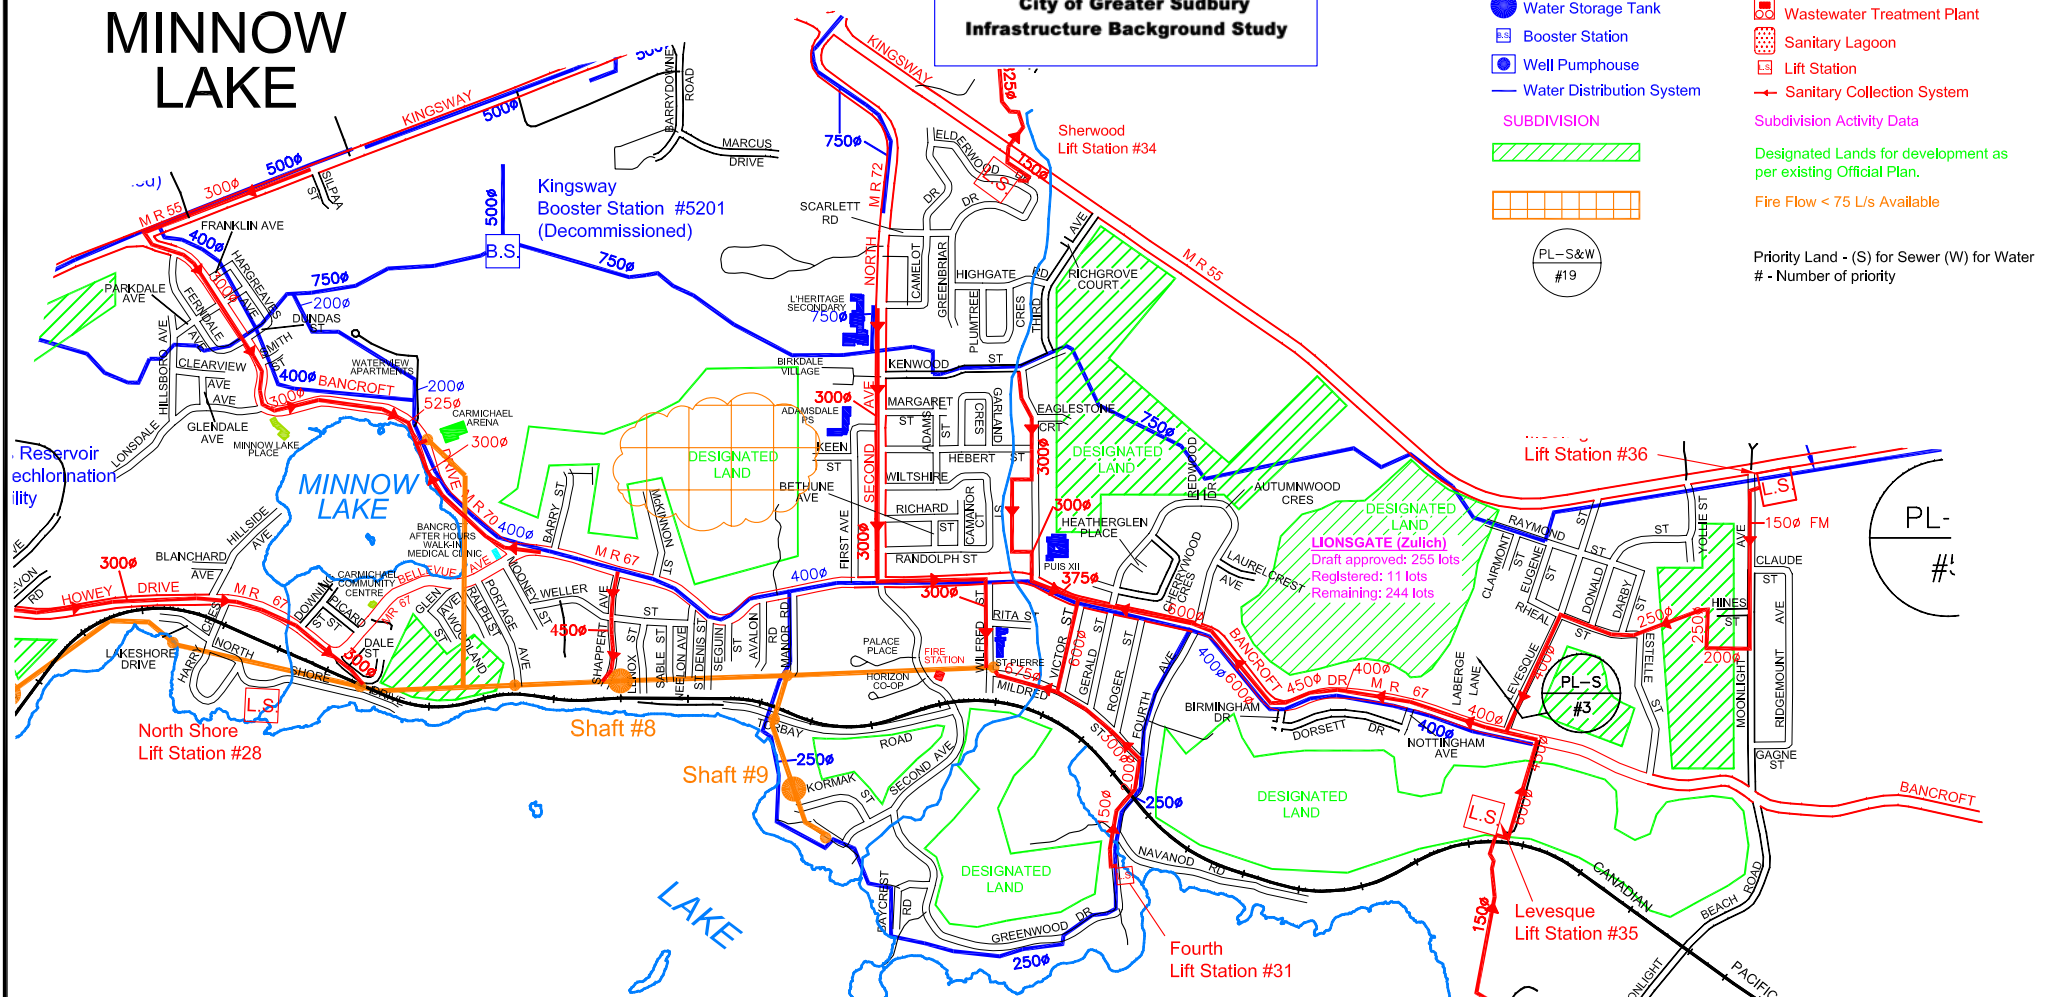

NOTE		R E V I S I O N S		
 DENNIS CONSULTANTS CIVIL ENGINEERS a division of R.V. Anderson Associates Limited	DATE	BY	DESCRIPTION	
	MAY 2005	S.N.S.	REVISED FINAL REPORT	
			MINNOW LAKE FIRE FLOW CONSTRAINTS	
	DRAWN BY: G.V.		DATE: MARCH 2005	N.T.S.
		FIGURE 3.3.6d		